


INDEX

- 1. SIMULATOR BLDG. (INCLUDING EOF) E-10061
- 2. SKILLS TRAINING BLDG. E-10016
- 3. WELDING & HF TRAINING H-10149
- 4. ATLANTA STEEL BLDG. N.A.
- 5. WAREHOUSE NO. 1 N.A.
- 6. WAREHOUSE NO. 2 D-10021
- 7. WAREHOUSE NO. 1 H-10020
- 8. SPARE
- 9. SPARE
- 10. SPARE
- 11. SPARE
- 12. WAREHOUSE NO. 5 N.A.
- 13. WAREHOUSE NO. 4 N.A.
- 14. VISITORS CENTER H-10054
- 15. SWITCHYARD SUPPORT BLDG. H-12620
- 16. ENVIRONMENTAL BLDG. H-10134
- 17. FIRST AID FACILITY/SAS H-12680
- 18. WAREHOUSE NO. 6 (PRODUCTION WH) H-10099
- 19. INTAKE STRUCTURE H-12610
- 20. DIESEL GENERATOR BLDG. H-12615
- 21. OFF GAS RECOMBINER BLDG. H-15899
- 22. SERVICE BLDG. H-14701
- 23. SERVICE BLDG. ANNEX H-20023
- 24. UNIT #1 TURBINE BLDG. H-12626
- 25. DECONTAMINATION CALIBRATION BLDG. H-12605
- 26. UNIT 1 RADWASTE BLDG. WEST WALL H-15700
- 27. UNIT 1 RADWASTE BLDG. ADDITION H-19004
- 28. UNIT 1 H.P.C.I. PUMP ROOM H-15011
- 29. UNIT 1 REACTOR BLDG. H-15200
- 30. UNIT 2 REACTOR BLDG. H-25941
- 31. UNIT 2 H.P.C.I. PUMP ROOM H-26128
- 32. UNIT 2 RADWASTE BLDG. WEST WALL H-25948
- 33. UNIT 2 RADWASTE LOADING DOCK H-19088
- 34. WATER TREATMENT PLANT H-12602
- 35. FIRE PUMP HOUSE FOUNDATION H-12600
- 36. FIRE EQUIPMENT BUILDING H-12614
- 37. RETROFIT (OUTAGE) SUPPORT BLDG. H-01336
- 38. GREENHOUSE
- 39. SECURITY TRAINING N.A.
- 40. LOW LEVEL RADWASTE BLDG. E-10047
- 41. BACKUP MET. TOWER D-10022
- 42. OUTAGE SUPPORT WAREHOUSE N.A.
- 43. WELD TEST BLDG. N.A.
- 44. CHLORINE BLDG. H-12678
- 45. UNIT 1 CIRC. WATER PUMP H-12223
- 46. WASTE GAS TREATMENT BLDG. H-15900
- 47. UNIT 2 CIRC. WATER PUMP H-23360
- 48. HOT MACHINE SHOP H-25981
- 49. COOLING TOWER SUPPORT BLDG. H-12621
- 50. DISCHARGE STRUCTURE H-12623
- 51. COOLING TOWER FAN MAINT. BLDG. N.A.
- 52. AUXILIARY SOLIDS H-12604
- 53. TECHNICAL SUPPORT CENTER H-25967
- 54. OFF GAS STACK H-15874
- 55. SEWAGE TREATMENT H-10107
- 56. FIRE PROTECTION TANKS N.A.
- 57. CONDENSATE STORAGE TANKS FDN. H-12608
- 58. UNIT 1 COOLING TOWER H-12518
- 59. UNIT 2 COOLING TOWER H-23348
- 60. NOAA WEATHER RADIO TOWER 19-509EJ
- 61. FIRE PROTECTION VALVE HOUSE H-20185
- 62. AUXILIARY CONTROL HOUSE H-20185
- 63. GATE 1 N.A.
- 64. PUMP HOUSE H-10023
- 65. UNIT #1 VALVE HOUSE N.A.
- 66. UNIT #2 VALVE HOUSE N.A.
- 67. MET. TOWER N.A.
- 68. DIESEL FUEL STORAGE TANKS H-43884
- 69. HYDROGEN AND OXYGEN STORAGE FACILITY
- 70. UNIT #2 TURBINE BLDG. H-22802 & H-22803
- 71. UNIT #1 CONTROL BLDG. H-12628
- 72. UNIT #2 CONTROL BLDG. H-12626
- 73. SALLY PORT(GATE 31A) N.A.
- 74. COMPUTER BLDG. H-10299
- 75. DOCUMENT STORAGE BLDG. N.A.
- 76. SECURITY BLDG. (PRES) H10240
- 77. MICROWAVE TOWER N.A.
- 78. C.A.S. BLDG. N.A.
- 79. CORK AND HOOK BLDG. N.A.
- 80. RECIRC. BLDG. (CONT. OUTAGE BLDG.) E-10174
- 81. TELECOMMUNICATIONS BLDG. N.A.
- 82. TRACTOR SHED N.A.
- 83. TIRE SHOP N.A.
- 84. FABRICATION SHOP N.A.
- 85. NRC BLDG. N.A.
- 86. SUPPLY SHED N.A.
- 87. WASTE OIL FACILITY N.A.
- 88. CABLE STORAGE BLDG. H-10217
- 89. GAS PUMPS AND STORAGE TANKS N.A.
- 90. HEALTH PHYSICS DRESS OUT BLDG. N.A.
- 91. RADWASTE SOLIDIFICATION PADS N.A.
- 92. INVESTMENT RECOVERY AREA N.A.
- 93. UNIT 1 HVAC CHILLER BLDG. H-43982 (H.P.C.I. ROOF)
- 94. UNIT 1 HELPER COOLING TOWER N.A.
- 95. UNIT 2 HELPER COOLING TOWER N.A.
- 96. COOLING TOWER ELECTRICAL BLDG. N.A.
- 97. UNIT 1 LIQUID NITROGEN STORAGE
- 98. UNIT 2 LIQUID NITROGEN STORAGE
- 99. UNIT 1 SERVICE WATER VALVE BOXES
- 100. UNIT 2 SERVICE WATER VALVE BOXES

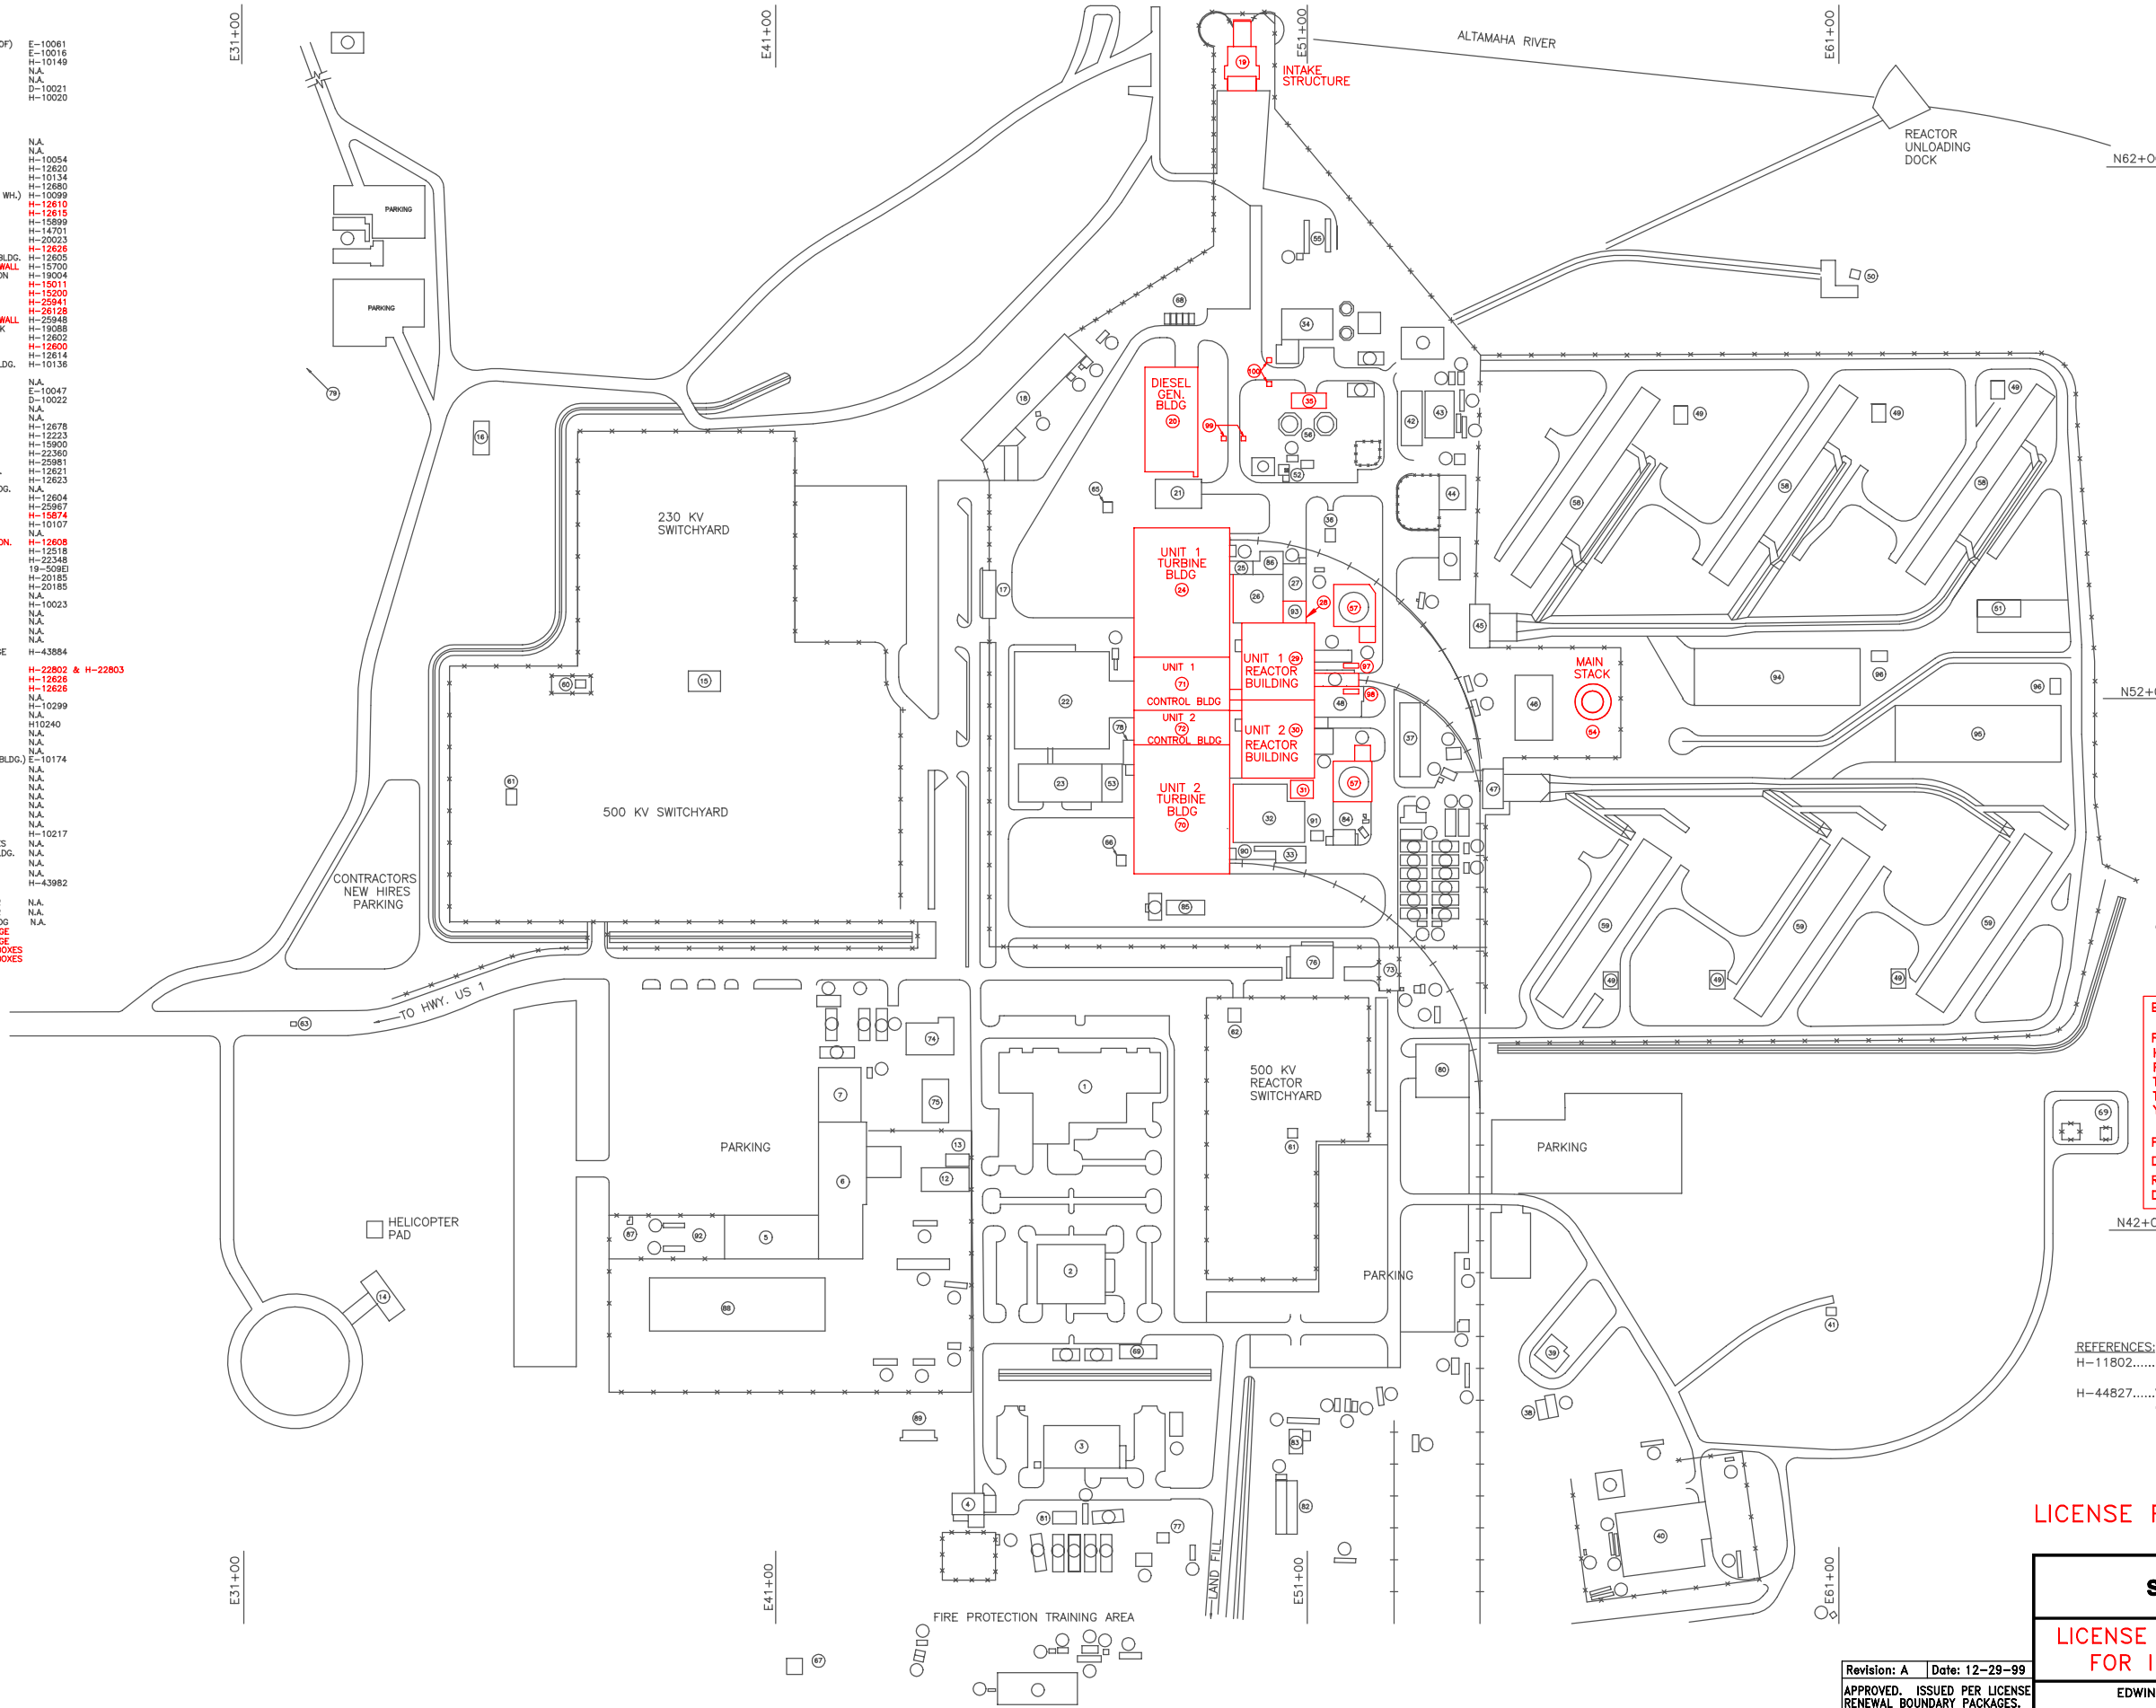

BOUNDARY DIAGRAM NO.:T23-B01-01

FUNCTION(S) NO.: F15-01, H11-01, H21-01, H21-02, L35-01, L48-01, R33-01, R33-02, T23-01, T24-01, T24-02, T29-01, T31-02, T52-01, T54-01, U29-01, W35-02, Y29-01, Y32-01, Y39-01, Z29-01

PREPARED BY: LARRY ORR
DATE: 12-31-99
REVIEWED BY: FAROOK CHANDIWALA
DATE: 12-31-99

REFERENCES:
H-11802.....FIRE HAZARDS ANALYSIS GENERAL BUILDING SITE PLAN
H-44827.....VEHICLE BARRIER SYSTEM OVERALL PLAN

LICENSE RENEWAL DOCUMENT

ACAD14 EL10173



LICENSE RENEWAL SCREENING FOR INFORMATION ONLY

EDWIN I. HATCH NUCLEAR PLANT
HATCH ELECTRIC
GENERATING PLANT
GENERAL BUILDING SITE PLAN

Revision: A Date: 12-29-99
APPROVED. ISSUED PER LICENSE RENEWAL BOUNDARY PACKAGES. DRAWING CREATED FROM E-10173, REV.7; BY TRM.

| | | |
|-----|-------|-------|
| BY | CHK'D | APPR. |
| TRM | WLO | ASK |

| DATE | SCALE | LOCATION | DOCUMENT NUMBER | REVISION |
|------|---------|----------|-----------------|----------|
| None | 1"=100' | 10-502 | EL-10173 | 0 |