
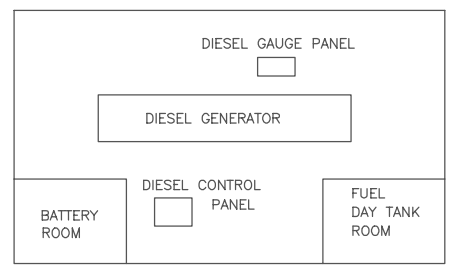


J
H
G
F
E
D
C
B
A

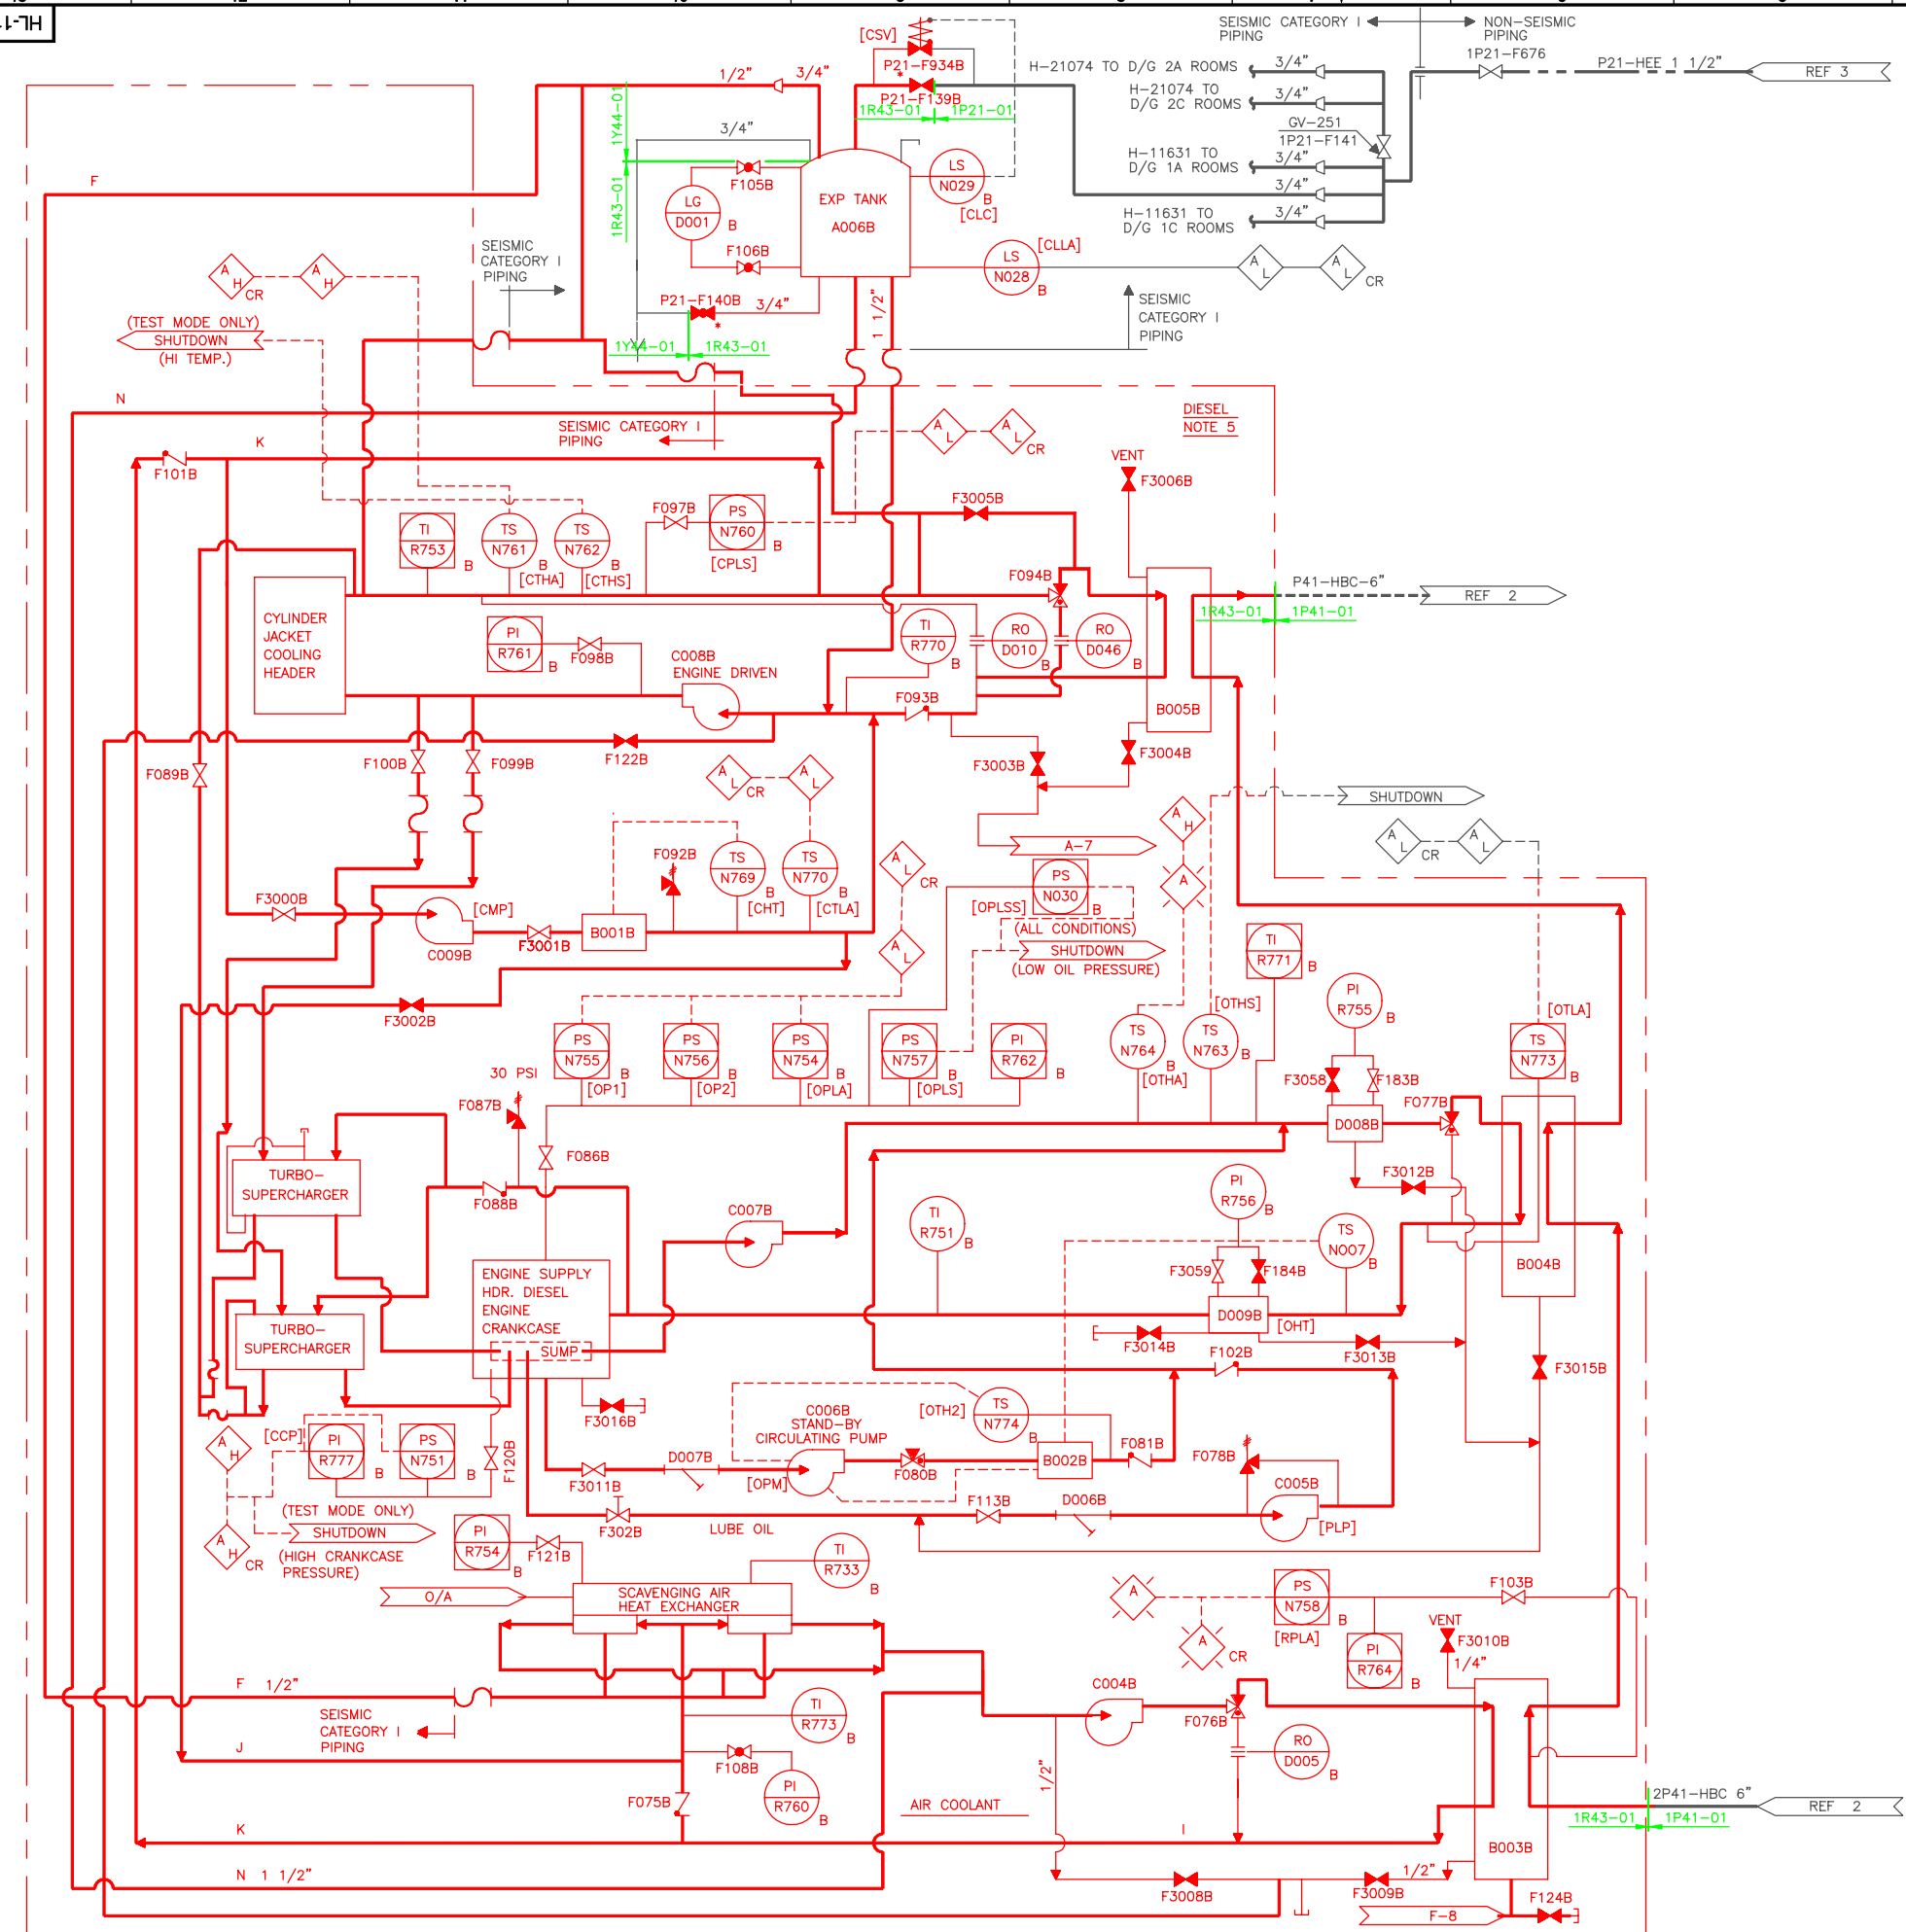

DIESEL ROOM LAYOUT

- NOTES:
1. ALL EQUIPMENT MPL NUMBERS PRECEDED BY R43 UNLESS OTHERWISE NOTED.
 2. THIS DRAWING ORIGINATED FROM VENDOR DRAWINGS S-13637 THRU S-13641
 3. ALL EQUIPMENT IS PROVIDED BY FAIRBANKS MORSE UNLESS OTHERWISE NOTED WITH AN ASTERISK (*)
 4. ALL PIPING EXTERNAL TO DIESEL SKID TO BE BY PIPING CONTRACTOR.
 5. EQUIPMENT MOUNTED ON DIESEL SKID
 6. [] FAIRBANKS MORSE DESIGNATIONS

- REFERENCES:
- | TITLE | MPL. NO. | DWG. NO |
|--------------------------------------|----------|---------------|
| 1. PIPING AND INSTRUMENT SYMBOLS | A42-1010 | S-15051 |
| 2. SERVICE WATER AT DIESEL GEN. P&ID | ----- | H-11600 |
| 3. DEMINERALIZED WATER SYSTEM P&ID | ----- | H-11038 |
| 4. FUEL OIL SYSTEM P&ID | ----- | H-11037 |
| 5. P&ID DIESEL GEN. 1A & 1C SHEET 1. | ----- | H-11631 SH. 1 |
| 6. P&ID DIESEL GEN. 1B SHEET 2. | ----- | H-11638 SH. 2 |
| 7. P&ID DIESEL GEN. 1A & 1C SHEET 2. | ----- | H-11631 SH. 2 |

BOUNDARY DIAGRAM NO.: 1R43-B01-05
 FUNCTION(S) NO.: 1R43-01
 PREPARED BY: Alex Morrison
 DATE: 12/18/98
 REVIEWED BY: William P. Evans
 DATE: 12/28/98

LICENSE RENEWAL DOCUMENT

MPL NO. R43 ACAD14 HL1163801

SOUTHERN COMPANY

LICENSE RENEWAL SCREENING FOR INFORMATION ONLY

EDWIN I. HATCH NUCLEAR PLANT UNIT No. 1
 P & I D
 DIESEL GENERATOR 1B
 SHEET 1

BY	CHK'D	APPR'D	DATE	SCALE	LOCATION	DOCUMENT NUMBER	REVISION
BKN	LCF			None	10-502	HL-11638	A

Revision: A Date: 11-11-99
 APPROVED, ISSUED PER LICENSE RENEWAL BOUNDARY PACKAGES. DRAWING CREATED FROM H-11638 SH.1, REV 18; BY BKN.