


FOR INFORMATION ONLY

PID-1-DG-D20462

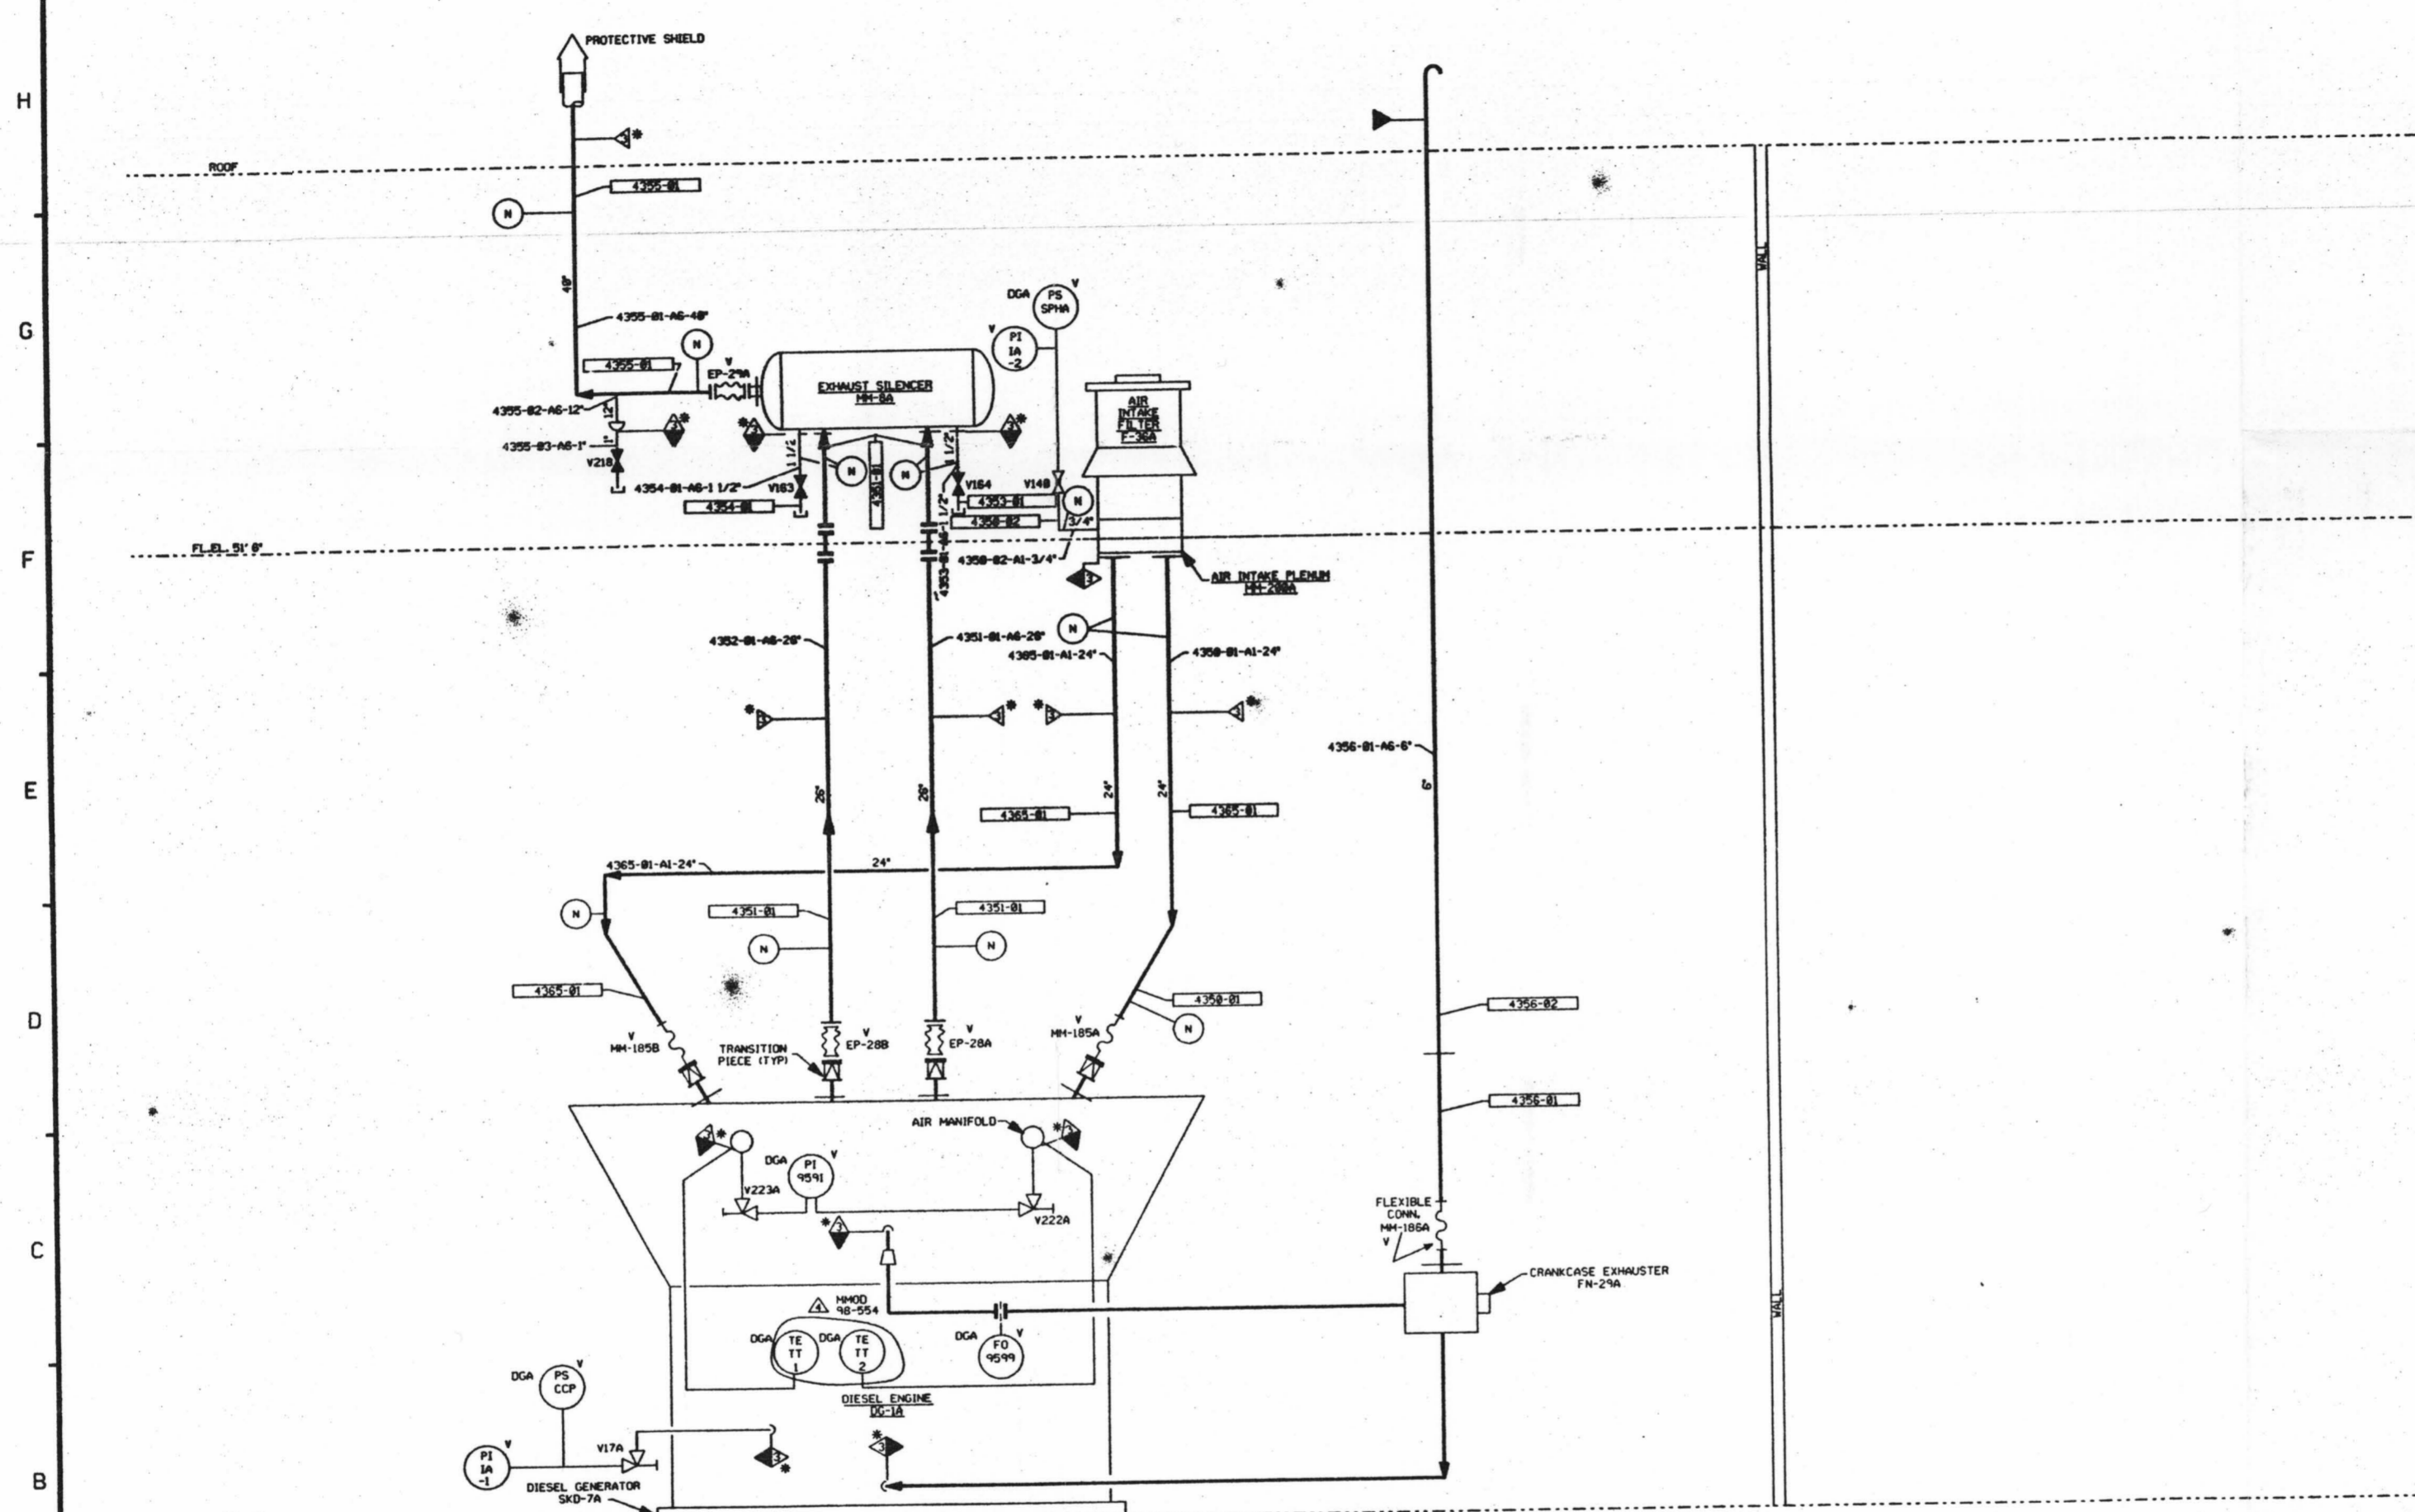

FOR PAID REFERENCE DRAWINGS SYMBOLS AND ABBREVIATIONS REFER TO DRAWINGS P&ID-LEGEND 1 AND P&ID-LEGEND 2.


LEGEND			
DESIGN	TEST	MIN. TEST	TEST
PRESSURE	PRESSURE	TEMP.	MEDIUM
Y	TEST BOUNDARY		
N	NO TEST REQUIRED		

- NOTES:
1. WORK THIS DRAWING WITH DRAWINGS 28456, 28457, 28458, 28459, 28468, & 28461.
 2. ALL LINES, EQUIPMENT, COMPONENTS AND INSTRUMENTATION HAVE SYSTEM PREFIX DG, UNLESS OTHERWISE NOTED.
 3. DELETED
 4. CLEARLINESS CLASS "B"
 5. Δ INDICATES REVISION LEVEL.
 6. SYSTEM DESCRIPTION NUMBER IS 50-18.
 7. VENT AND DRAIN CODE AND SAFETY CLASS BREAKS -S- AT THE DOWNSTREAM END OF THE OUTER ISOLATION VALVE PER DESIGN STANDARDS I-NRY-SB011 UNLESS NOTED OTHERWISE.

REV	DATE	DSGN	DRWN	CHKD	CODE	SEC	DESCRIPTION
4	11/11	BCS					INCORP. H400 '88954 DCN. B&I
3	7/28/17	MPW					INCORP. H400 '88958 DCN. B1
2	4/2/96	BCL					INCORP. DCR '94-12 CAB. B1
1	10/7/88	PAL	DVS	HAP	VNK	PRC	ADDED PIPE & CAP PER ERECTION ISOL. ADDED DGA/LINOLESA "FOR VENDOR PER USE. P&ID ADDED FOREIGN PRINTS. HITD TO REF. BLOC." 3 NOTES 5&6 ISSUED FOR OPERATIONS

REF. DRAWING NO.	REV.	TITLE
4763-F-28828	03	DIESEL GENERATOR AIR SYSTEM-HITD
FP28529	04	EMERG DG INTK. EXT. 4 & CRNK SCHEM
FP28963	00	EMERG DG AIR INLET FILTER (DRY TYPE)
FP28948	07	EMERG DG EXHAUST SIL. 48 INCH 20" INLETS
4763-F-282181	13	DIESEL GENERATOR AIR SYSTEM P&ID

North Atlantic Energy Service Corporation

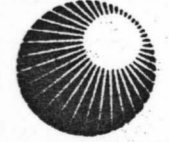

DIESEL GENERATOR INTAKE, EXHAUST & CRANKCASE VACUUM SYSTEM TRAIN "A" DETAIL

PID- 1-DG-D20462

D-25