



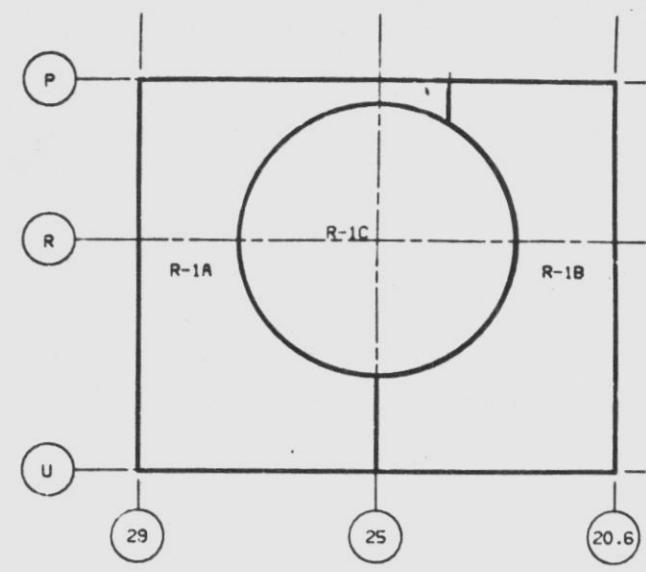

A
B
C
D
E
F
G
H

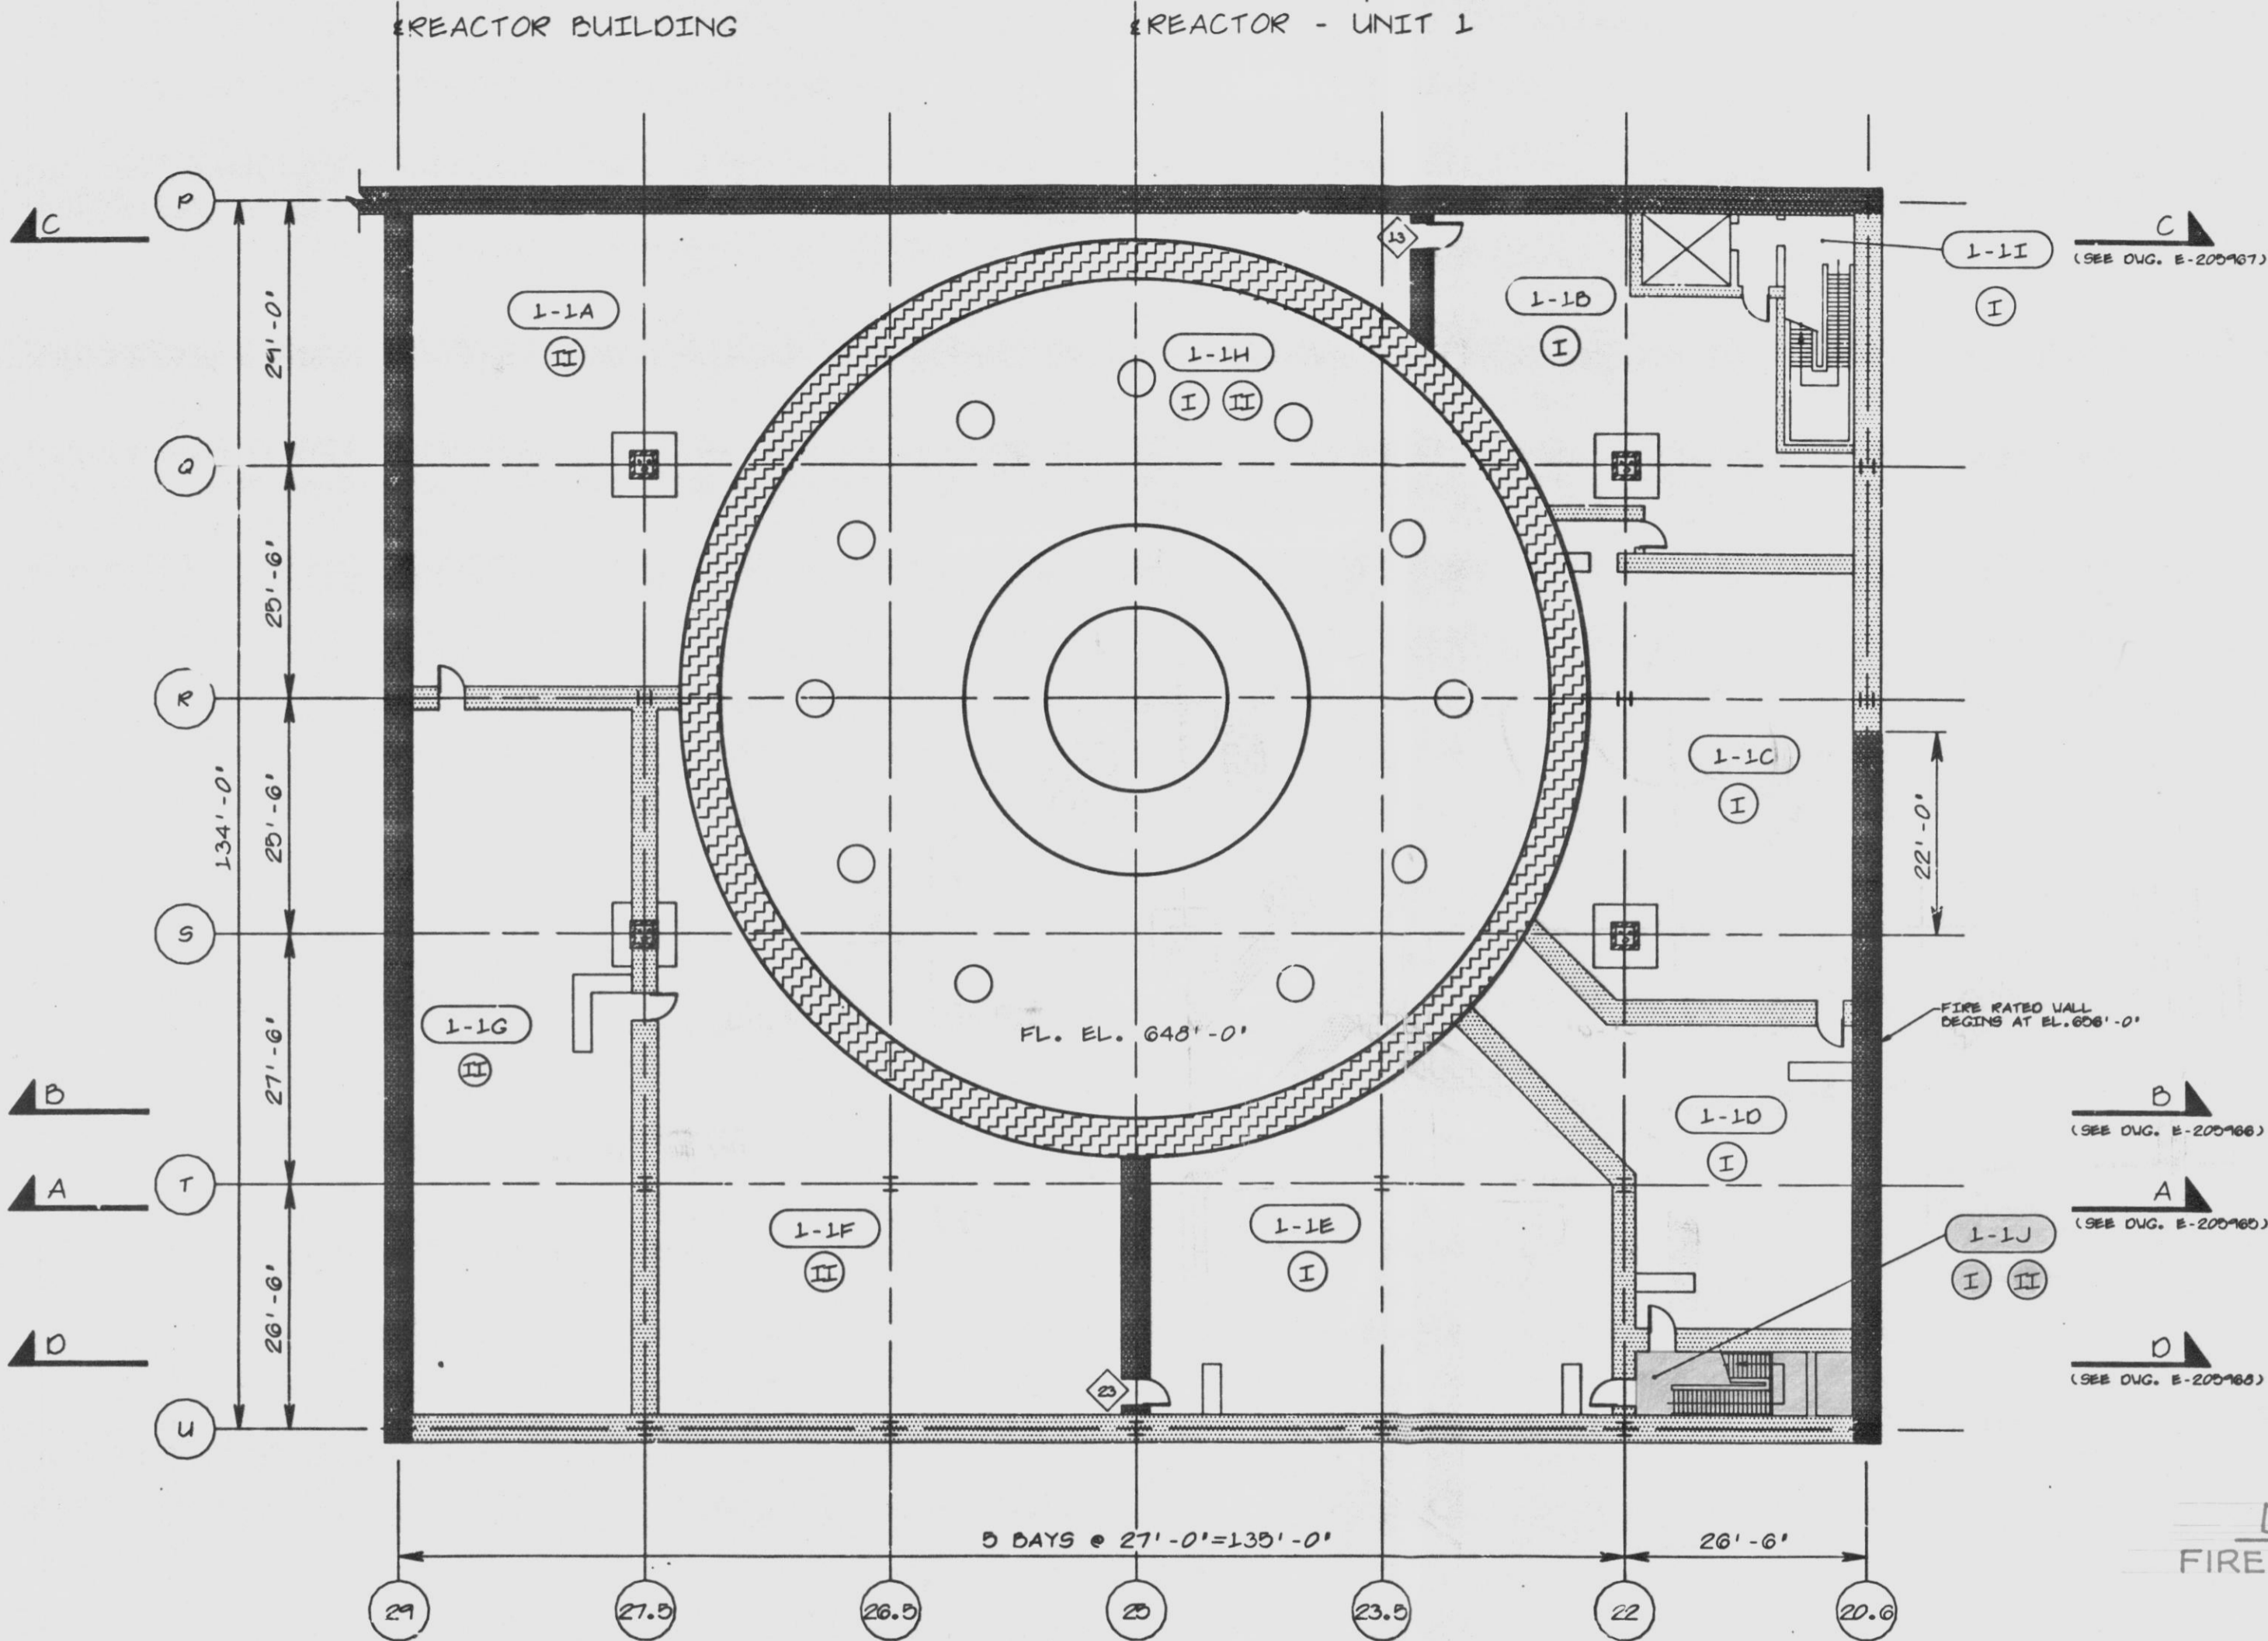

FIRE AREA KEY PLAN

FLOOR PLAN @ EL. 645'-0"

NOTES
 1) PROTECTED SAFE SHUTDOWN PATH (I.E. DIVISION) IS DEFINED AS JOSE SAFE SHUTDOWN CABLES AND COMPONENTS WHICH MUST BE PROTECTED FROM FIRE DAMAGE WITHIN THE DESIGNATED FIRE ZONE. WHERE BOTH DIVISIONS ARE SHOWN, BOTH DIVISIONS MUST BE PROTECTED.

DEVIATION REQUEST NO. 14
 FIRE ZONES WITHOUT FIRE DETECTION

	E-184302. SHT. 1
A-11	E-105004. SHT. 1
C-1739	E-205968
C-1738	E-205967
C-1737	E-205966
C-1736	E-205965
AE DRAWING NO.	PPAL DRAWING NO.

LEGEND

	FIRE ZONES		FIRE ZONE BOUNDARY
	DIVISION I PROTECTED SAFE SHUTDOWN PATH		INERTED CONTAINMENT BOUNDARY
	DIVISION II PROTECTED SAFE SHUTDOWN PATH		
	3 HR. FIRE-RATED WALLS		
	FIRE DOOR NUMBER		

REFERENCE DRAWINGS		
2	ADDED FIRE AREAS	BOB [initials]
1	PER ENGINEERING INFO.	BOB [initials]
0	INITIAL ISSUE	BOB [initials]
REV.	DESCRIPTION	DR / CR / APPROVED / DATE
NON-QUALITY RELATED		
SUSQUEHANNA S.E.S.		
UNIT 1		
REACTOR BUILDING		
FIRE ZONE PLAN OF		
ELEVATION 645'-0"		
AREA 25,27,28,29 ELEV. 645'-0" SCALE 1/8"=1'-0"		
PENNSYLVANIA POWER & LIGHT COMPANY		
ALLENTOWN PA.		
PPAL DRAWING NO.	SHEET NO.	REV. NO.
E205949	1	2
AE DRAWING NO.	SHEET NO.	
C-1720	1	

FRACTIONAL DECIMAL

30X I CERTIFY THAT THE IMAGE CONTAINED ON THIS FRAME WAS MADE IN THE NORMAL AND REGULAR COURSE OF BUSINESS, ON THE DATE STATED BELOW, AND THAT IT IS AN ACCURATE REPRODUCTION OF THE DOCUMENT SUBMITTED TO SPWC CORRESPONDENCE AND DRAWING FILES.

G 1 9 2 2

SAVED AS A/D DRAWING NAME ST0047

812200/53 SI APERTURE CARD