


CONTROLLED at 8/2/1994 09:44:36 As-Built for RG28401. Image generated - cannot be reproduced per NR-QA-005

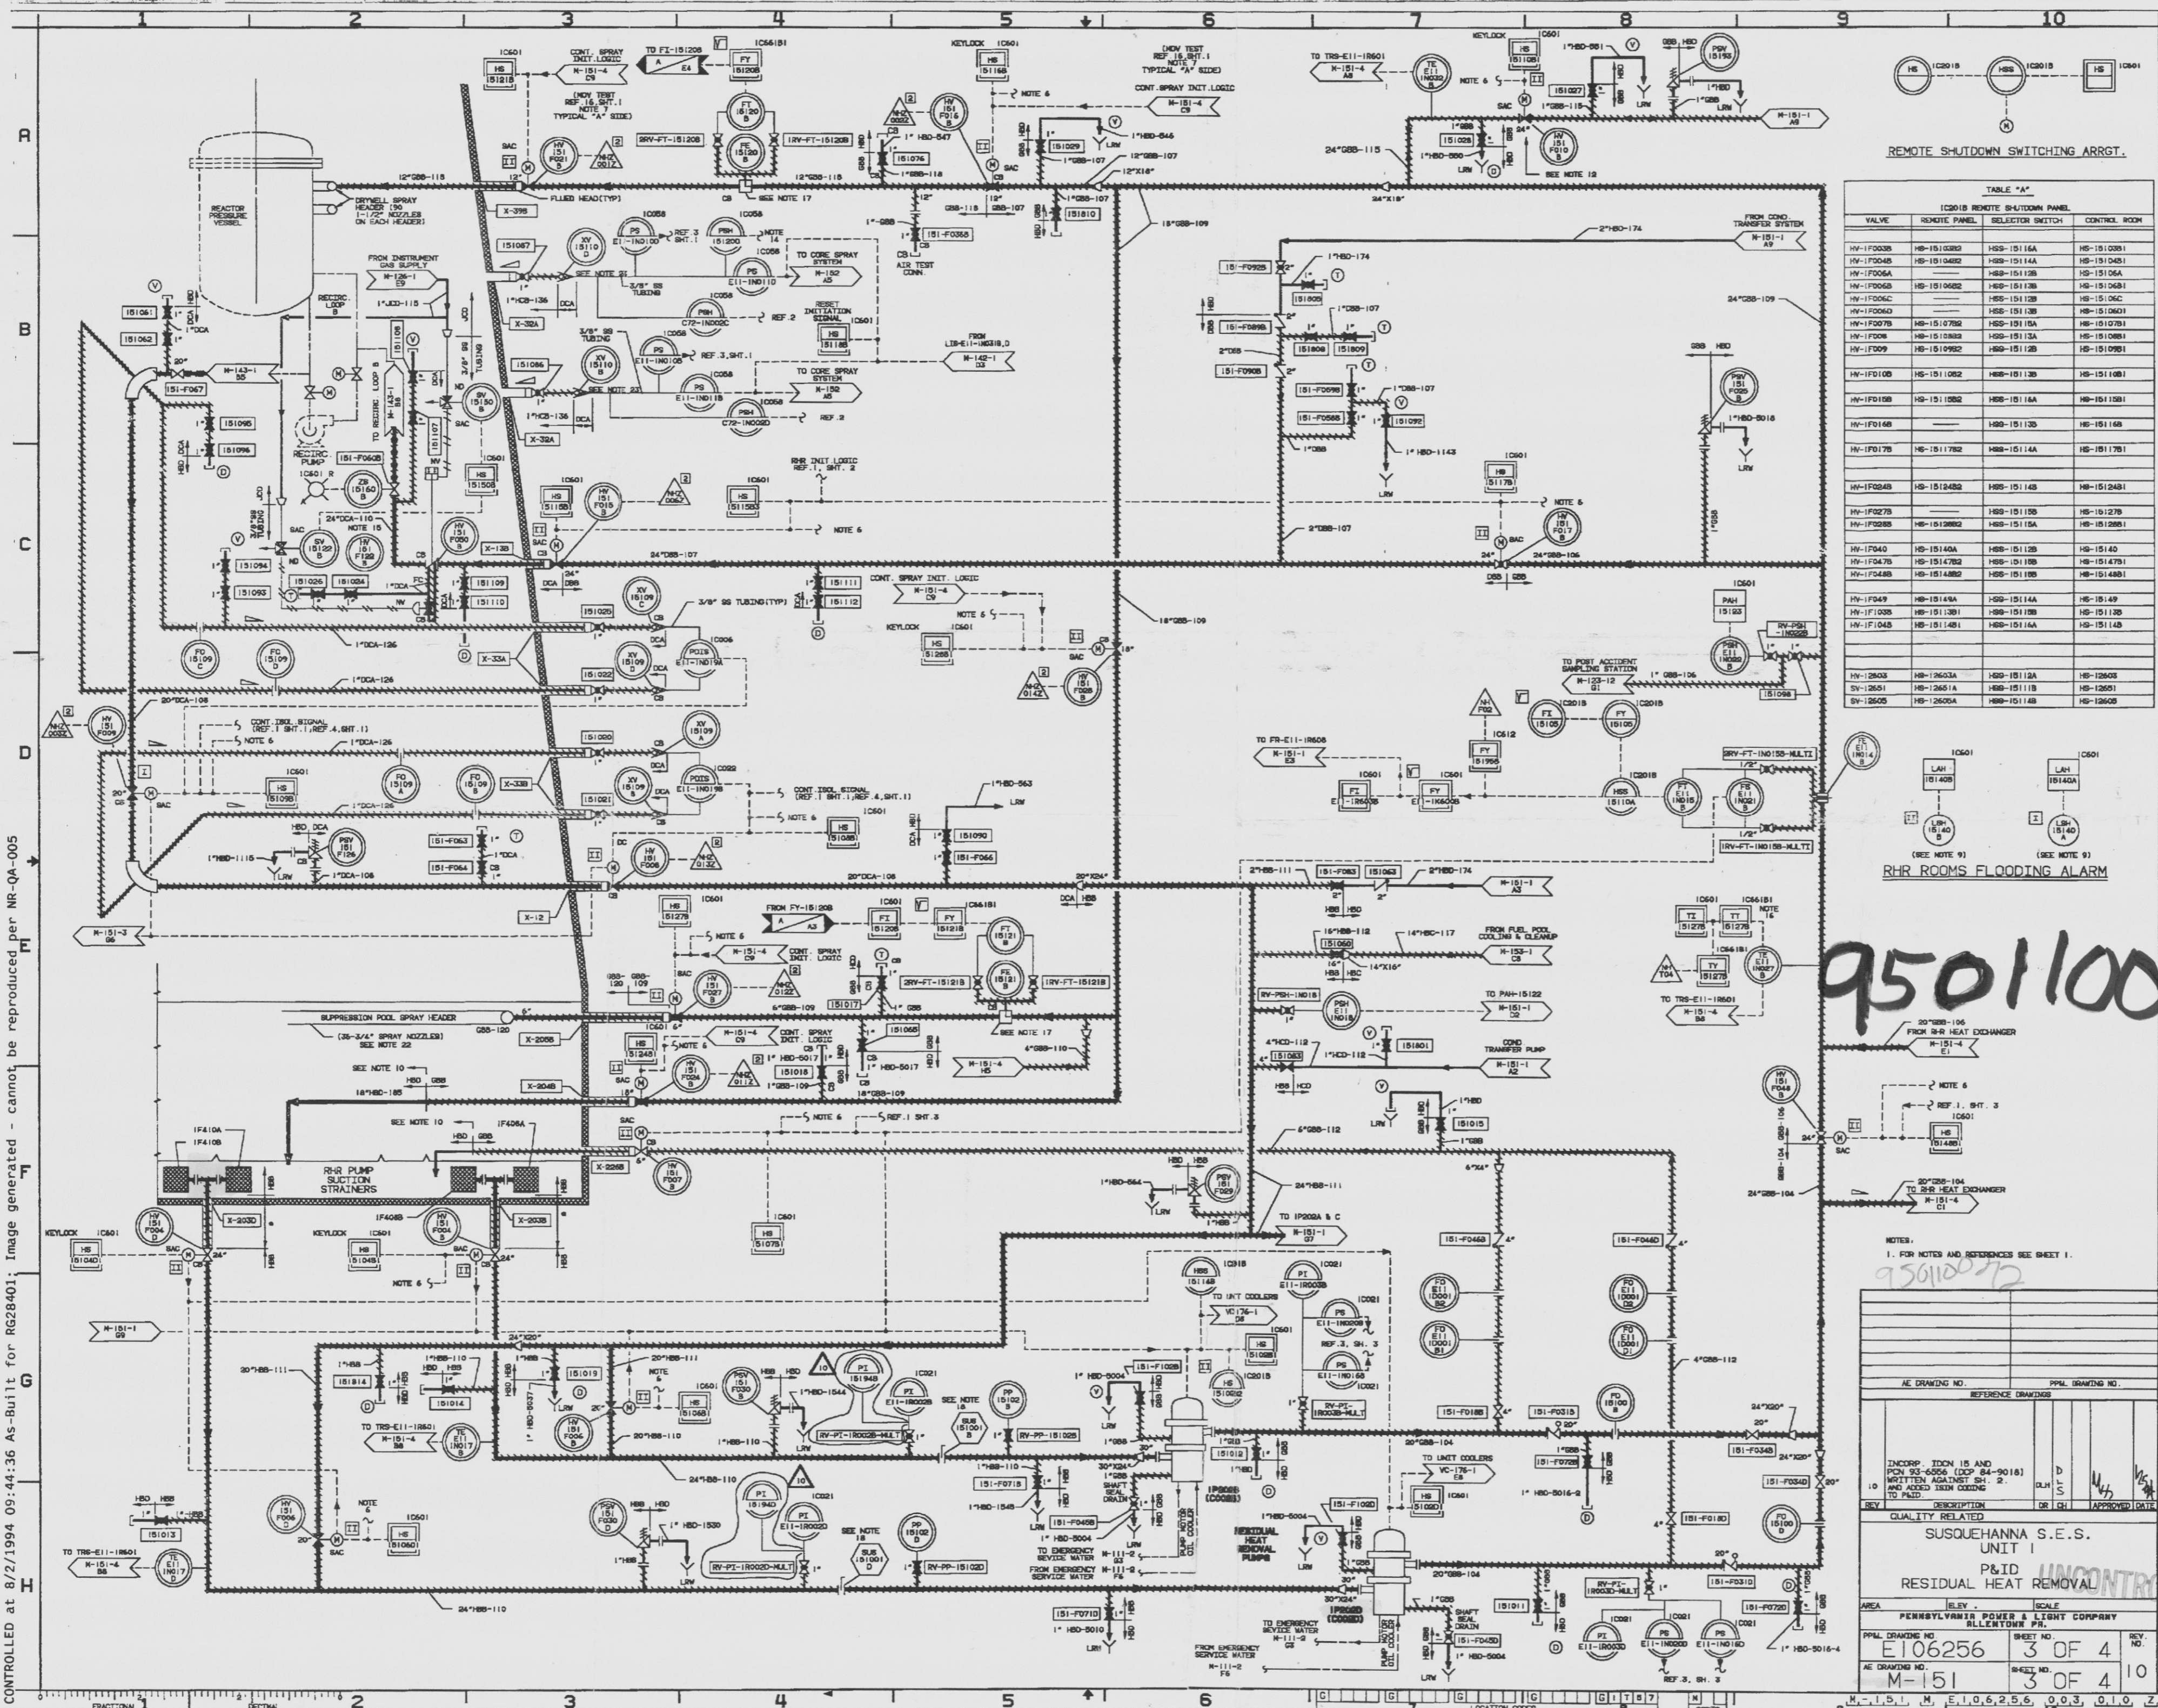

REMOTE SHUTDOWN SWITCHING ARRGT.

TABLE "A"
IC2018 REMOTE SHUTDOWN PANEL

VALVE	REMOTE PANEL	SELECTOR SWITCH	CONTROL ROOM
HY-1F003B	HS-15103B2	HSS-15116A	HS-15103B1
HY-1F004B	HS-15104B2	HSS-15116A	HS-15104B1
HY-1F005A	HS-15105A	HSS-15112B	HS-15105A
HY-1F005B	HS-15105B2	HSS-15112B	HS-15105B1
HY-1F006C	HS-15106C	HSS-15112B	HS-15106C
HY-1F006D	HS-15106D	HSS-15112B	HS-15106D
HY-1F007B	HS-15107B2	HSS-15115A	HS-15107B1
HY-1F008	HS-15108B2	HSS-15113A	HS-15108B1
HY-1F009	HS-15109B2	HSS-15112B	HS-15109B1
HY-1F100B	HS-15110B2	HSS-15113B	HS-15110B1
HY-1F101B	HS-15111B2	HSS-15116A	HS-15111B1
HY-1F101B	HS-15111B2	HSS-15113B	HS-15111B
HY-1F101B	HS-15111B2	HSS-15114A	HS-15111B1
HY-1F202A	HS-151202A	HSS-15114B	HS-151202A1
HY-1F202B	HS-151202B	HSS-15115B	HS-151202B1
HY-1F202C	HS-151202C	HSS-15115A	HS-151202C1
HY-1F202D	HS-151202D	HSS-15112B	HS-151202D1
HY-1F202E	HS-151202E	HSS-15112B	HS-151202E1
HY-1F202F	HS-151202F	HSS-15112B	HS-151202F1
HY-1F202G	HS-151202G	HSS-15112B	HS-151202G1
HY-1F202H	HS-151202H	HSS-15112B	HS-151202H1
HY-1F202I	HS-151202I	HSS-15112B	HS-151202I1
HY-1F202J	HS-151202J	HSS-15112B	HS-151202J1
HY-1F202K	HS-151202K	HSS-15112B	HS-151202K1
HY-1F202L	HS-151202L	HSS-15112B	HS-151202L1
HY-1F202M	HS-151202M	HSS-15112B	HS-151202M1
HY-1F202N	HS-151202N	HSS-15112B	HS-151202N1
HY-1F202O	HS-151202O	HSS-15112B	HS-151202O1
HY-1F202P	HS-151202P	HSS-15112B	HS-151202P1
HY-1F202Q	HS-151202Q	HSS-15112B	HS-151202Q1
HY-1F202R	HS-151202R	HSS-15112B	HS-151202R1
HY-1F202S	HS-151202S	HSS-15112B	HS-151202S1
HY-1F202T	HS-151202T	HSS-15112B	HS-151202T1
HY-1F202U	HS-151202U	HSS-15112B	HS-151202U1
HY-1F202V	HS-151202V	HSS-15112B	HS-151202V1
HY-1F202W	HS-151202W	HSS-15112B	HS-151202W1
HY-1F202X	HS-151202X	HSS-15112B	HS-151202X1
HY-1F202Y	HS-151202Y	HSS-15112B	HS-151202Y1
HY-1F202Z	HS-151202Z	HSS-15112B	HS-151202Z1
HY-12603	HS-12603A	HSS-15112A	HS-12603
HY-12604	HS-12604A	HSS-15111B	HS-12604
HY-12605	HS-12605A	HSS-15114B	HS-12605

RHR ROOMS FLOODING ALARM

9501100272

NOTES:
1. FOR NOTES AND REFERENCES SEE SHEET 1.

INCORP. IDON 15 AND PEN 93-6556 (DCP 84-9018) NOTED AGAINST SH. 2. AND ADDED ISM COOLING TO PAID.

REV	DESCRIPTION	DATE	APPROVED

SUSQUEHANNA S.E.S. UNIT 1
P&ID
RESIDUAL HEAT REMOVAL

PPAL DRAWING NO.	SHEET NO.	SCALE	REV. NO.
E106256	3 OF 4		
M-151	3 OF 4		10

UNCONTROLLED COPY

Docket # 50-287
Accession # 9501040155-03
Date 12-28-94
Regulatory Docket File

ANSTEC APERTURE CARD