


Figure 8a2.2-1 – One-Line Diagram – Uninterruptible Electrical Power Supply System

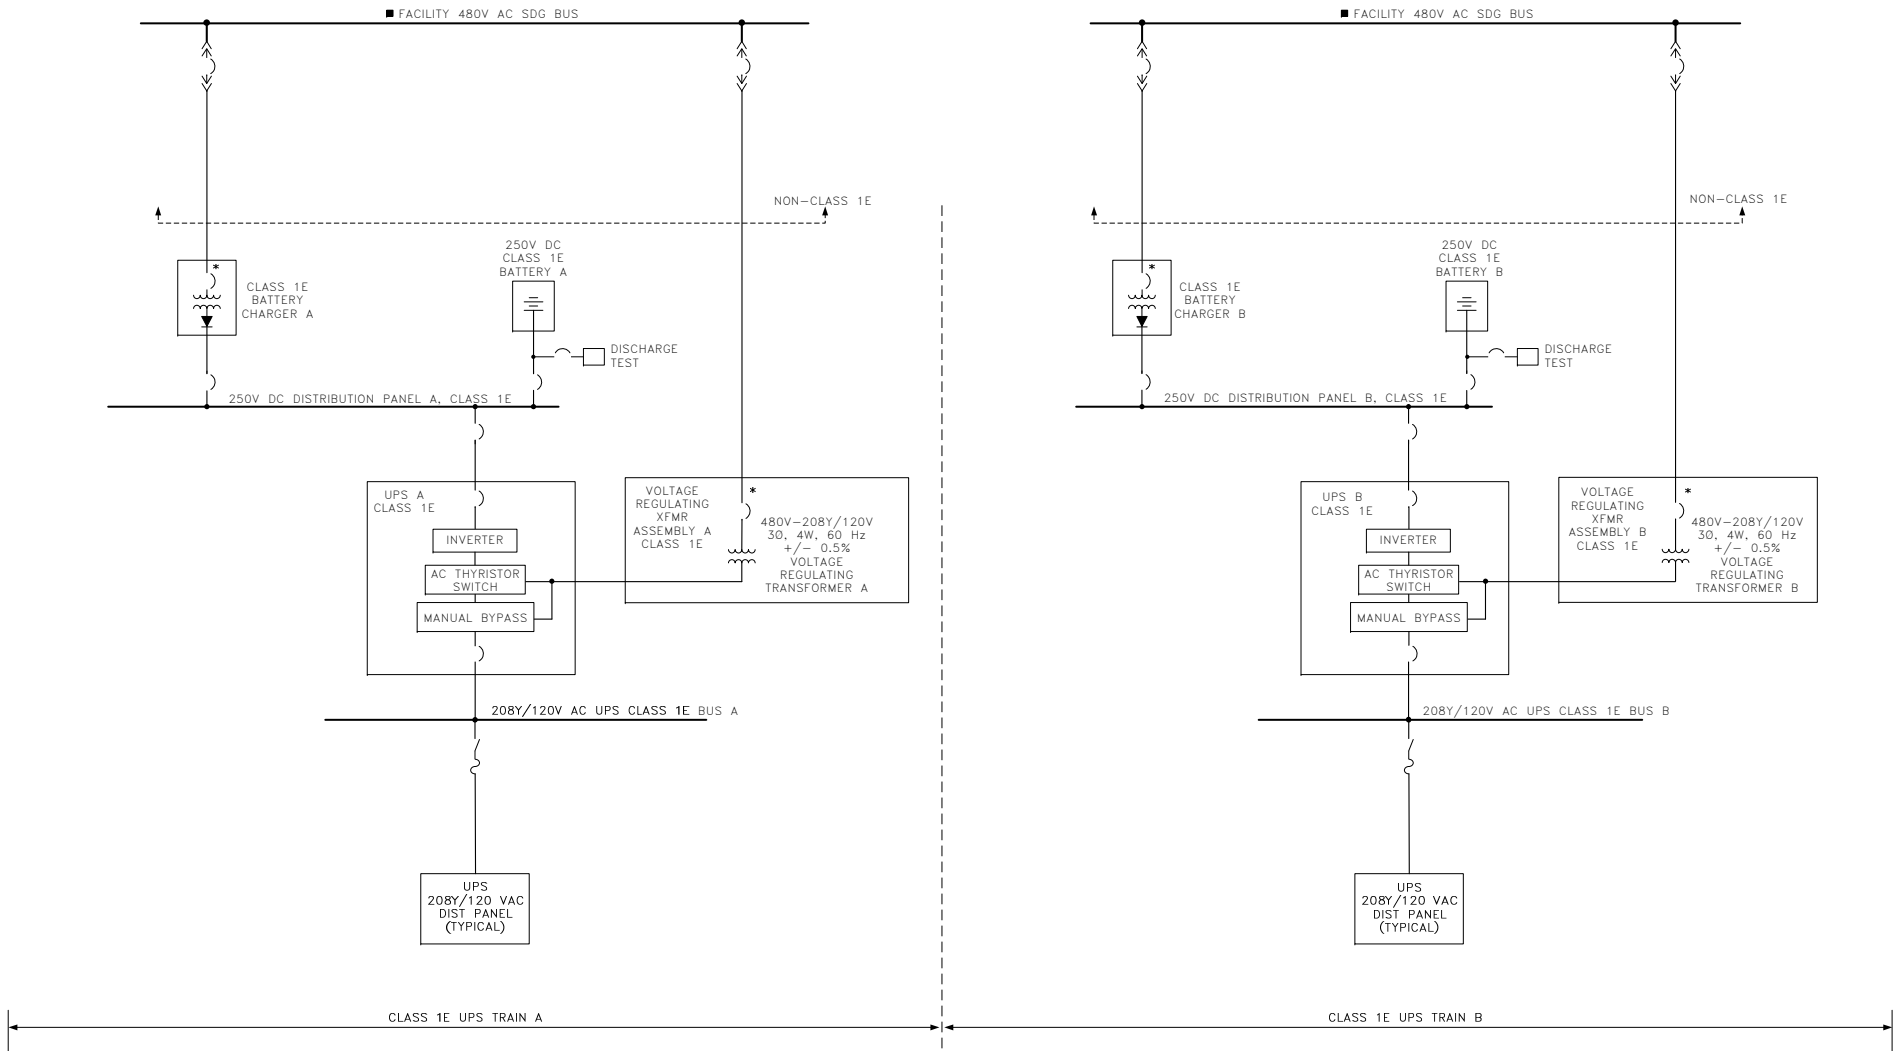

LEGEND:  
 \* NON-CLASS 1E TO CLASS 1E ISOLATOR  
 ■ FACILITY ONE-LINE DIAGRAM DRAWING NUMBER LATER